



THESE DRAWINGS PROVIDE A GENERIC OVERVIEW OF THE INSTALLATION. THEY ARE NOT PROJECT SPECIFIC OR REFLECT ANY CUSTOMIZATION UNLESS NOTED. PLEASE CONTACT VORTEX AQUATIC STRUCTURES INTERNATIONAL FOR MORE DETAILS.

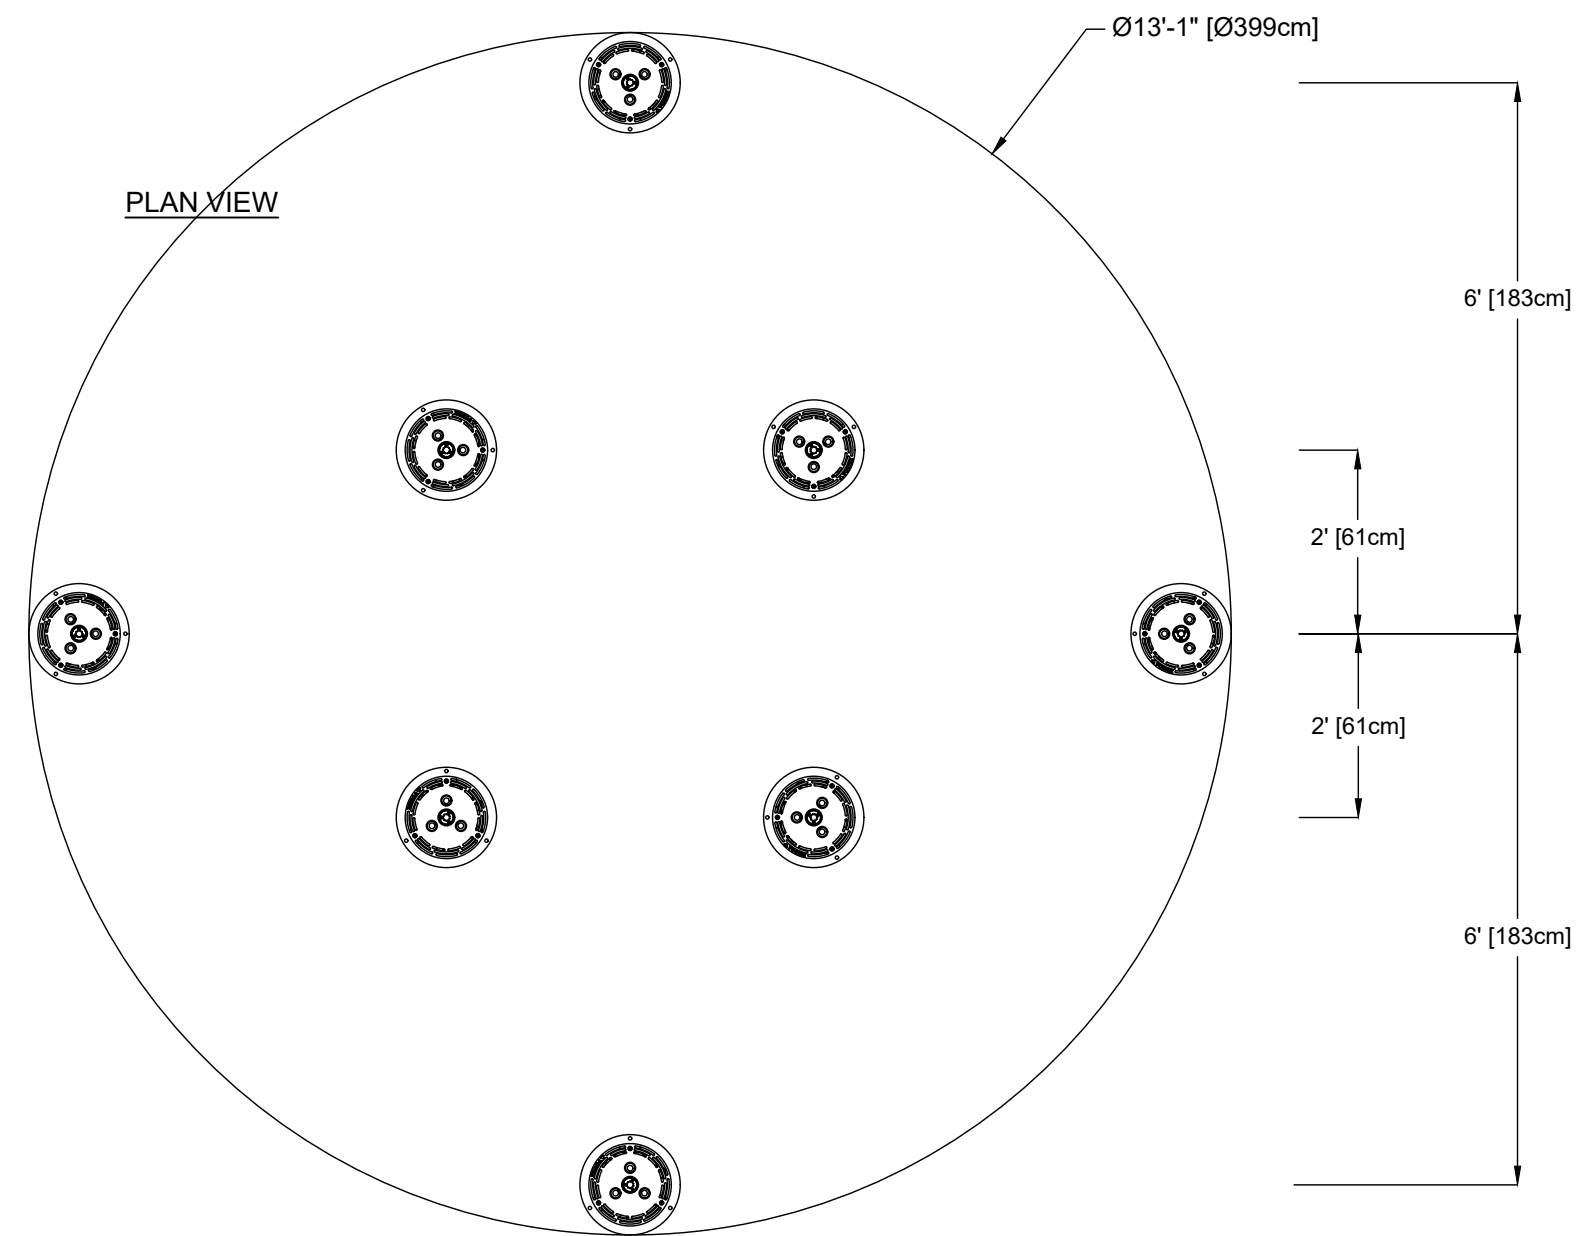


NOTES:

- 1) SEE THE PIPING AND CONNECTION DIAGRAM FOR PLACEMENT AND DRAINAGE NEEDED.
- 2) DISTANCE BETWEEN JETS CAN BE CHANGED, BUT WATCH OUT FOR SPRAYZONE CHANGE. AGAIN REFER TO PIPING AND CONNECTION DIAGRAM

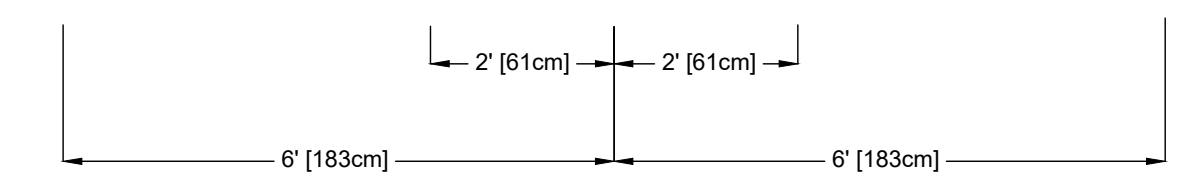

FRONT ELEVATION VIEW

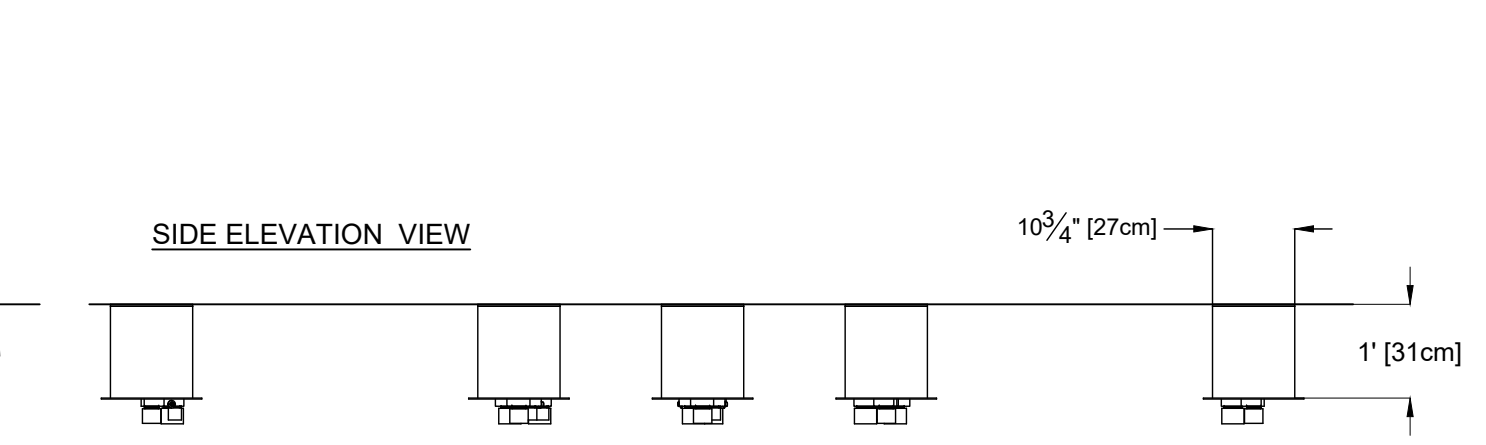

SIDE ELEVATION VIEW

X8 VOR 7059 LUMIFLOW  
 INSTALLATION KIT LUMIFLOW #103536 (55000.0846)

PRODUCT NAME: COREOPLAY OCEAN		DATE: 13-02-2023		SHEET NO: 1/1		11"x17" SHEET SIZE	
PRODUCT NUMBER: VOR 7062							

