



PLAN VIEW

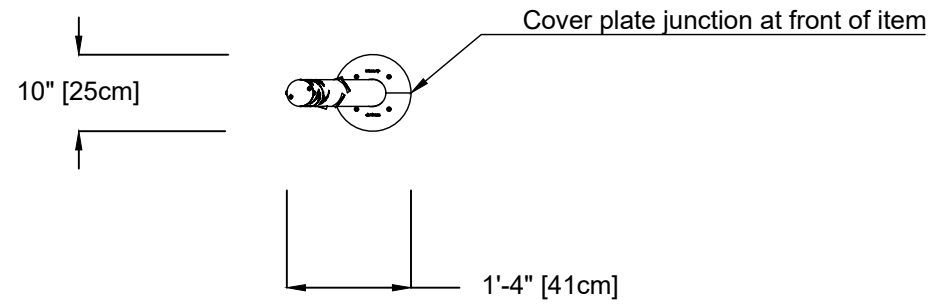


SAFESWAP ORIENTATION VIEW

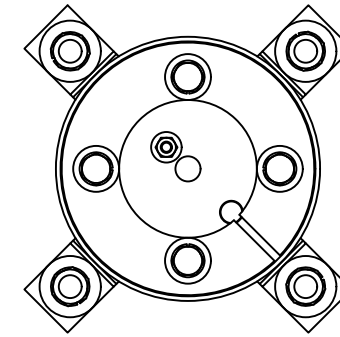

THE PRODUCT SHOULD BE CONNECTED TO DRINKING WATER.

SIDE ELEVATION VIEW

FRONT ELEVATION VIEW

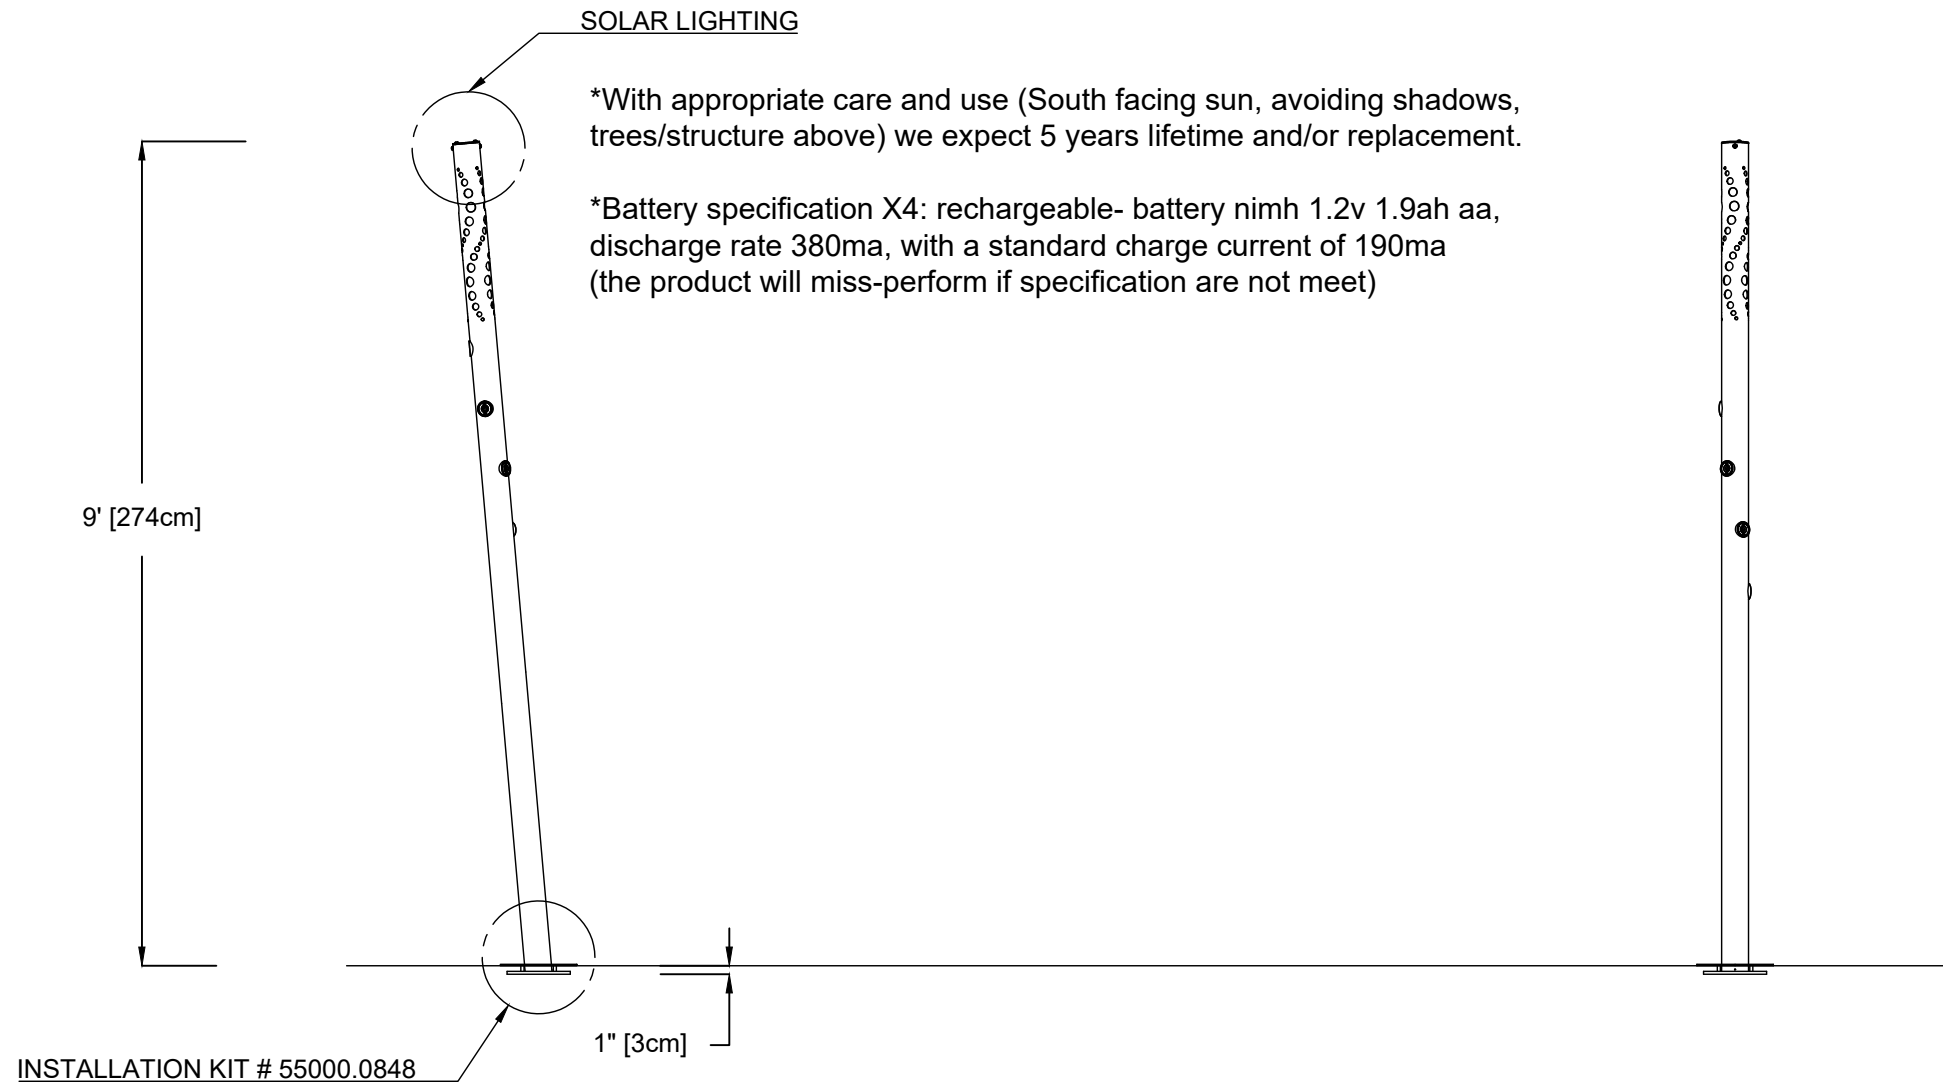

PRODUCT NAME: GLOMIST

PRODUCT NUMBER: 7247.200X

DATE: 09/19/2022

PRODUCT INFORMATION

SHEET NO: 1/1

11"x17" SHEET SIZE



DRINKING WATER LINE INLET 1" (25mm) NPT. (FEMALE)  
 MIN. 2° SLOPE BACK TO WATER SUPPLY. REFER TO  
 CONSTRUCTION DOCUMENTS FOR LINE SIZE DETAILS.  
 (LINE CONNECTION SUPPLIED BY INSTALLER)

1/2" (13mm) DRAIN LINE MIN. 2° SLOPE BACK TO DRAINAGE.  
 REFER TO CONSTRUCTION DOCUMENTS FOR LINE SIZE  
 DETAILS. (LINE CONNECTION SUPPLIED BY INSTALLER)


3/8" (10mm) EARTH  
 GROUNDING STUD

SAFESWAP™ ANCHORING SYSTEM TO BE  
 INSTALLED LEVEL, PLUMB & FLUSH TO  
 FINISHED GRADE DIA. 8 5/8" (219mm)

4 X 3/4" (20mm) S.S. HEIGHT & LEVELING CONTROL  
 ANCHOR STUDS WITH HARDWARE.  
 DRILL & EPOXY GROUT STUDS (DONE BY INSTALLER)

CONCRETE SURFACE. VERIFY LOCAL  
 CODES FOR TYPE, THICKNESS &  
 REINFORCEMENT REQUIREMENTS

#5 (15M) REBAR  
 12" (30cm) C/C BOTH DIRECTIONS  
 3'(91cm) LENGTH (SUPPLIED BY INSTALLER)

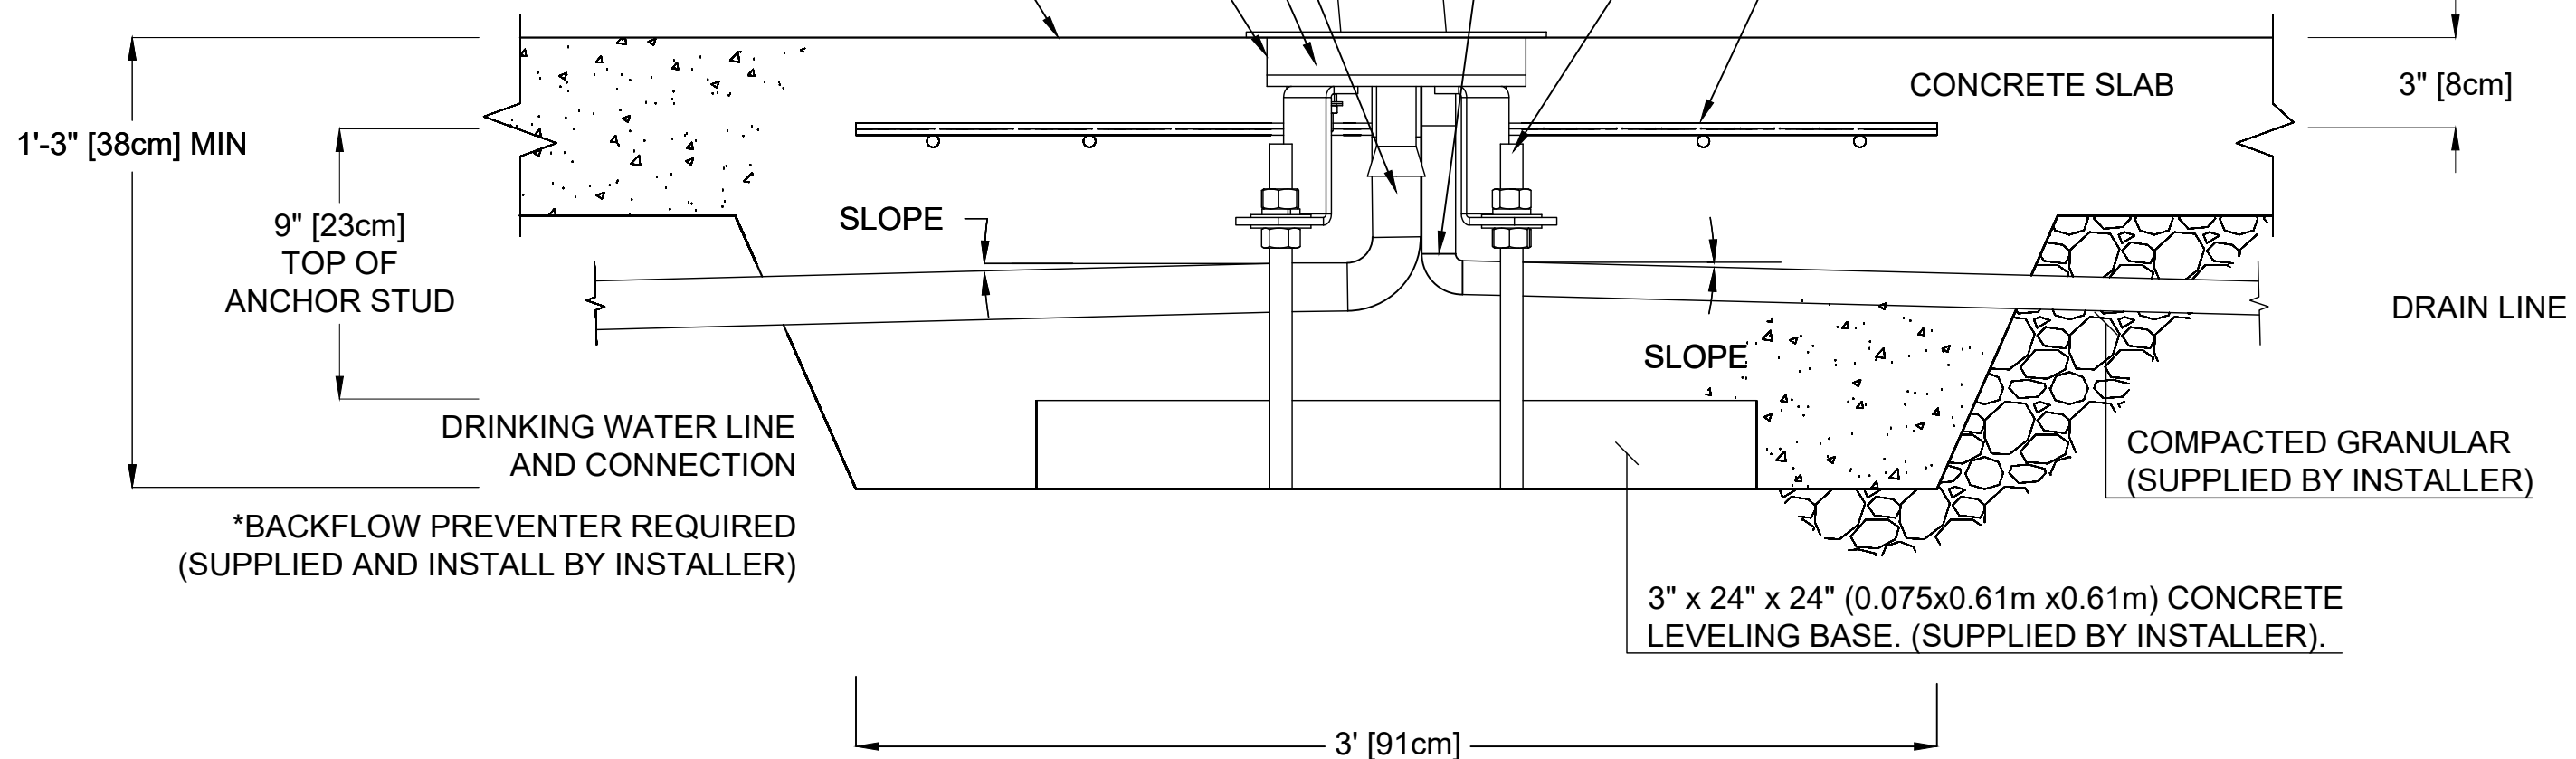

PRODUCT NAME: INSTALLATION KIT GLOMIST

PRODUCT INFORMATION

PRODUCT NUMBER: 55000.0848

DATE: 09/29/21

SHEET NO: 1/1

11"x17" SHEET SIZE

